

- ① TWO PIECE COMPRESSION TRIM  
COLOR BLACK
- ② SPLIT FACE CMU - SEE COLORS BELOW
- ③ STONE VENEER 4 TOP CAP - ENVIRONMENTAL  
STONE MATERIAL M1
- ④ 3'-4" UD x 4" DP. FILASTERS-STONE VENEER  
BASE-SPLIT FACE CMU
- ⑤ 2' SQ CANOPY COL-STONE VENEER BASE  
-SPLIT FACE CMU
- ⑥ STUCCO FINISH OVER STOREFRONT  
COLOR C1
- ⑦ 12" STUCCO BAND - 1" PROJECTION  
COLOR COLOR C3
- ⑧ DECORATIVE CORNICE W/ STUCCO FINISH  
COLOR C3
- ⑨ WALL MOUNTED LIGHT FIXTURE COLOR  
BRONZE
- ⑩ PAINT MAN DOOR RED 4 METAL FRAMES  
BLACK
- ⑪ DO NOT PAINT OVERHEAD DOOR PAINT  
ANGLES BLACK
- ⑫ ALUMINUM STOREFRONT - RED KYNAR FINISH
- ⑬ GLASS AND ALUMINUM DOORS - CLEAR  
ANODIZED FINISH
- ⑭ FRONT WALL SIGN - 36" CHANNEL NSTRP
- ⑮ RIGHT WALL SIGN - 36" CHANNEL NSTRP
- ⑯ SCUPPERS AND DOWNSPOUTS.  
PAINT TO MATCH BACK GROUND  
ADJACENT 4"H. X 6"W. OVERFLOW SCUPPER  
FLOWLINE 2" ABOVE ROOF.
- ⑰ TOILET WALL VENTS PAINT COLOR C3
- ⑱ ROOF LINE SCREENED BY PARAPET
- ⑲ PIPE GUARD WITH RED SLEEVE

## 2 ELEVATION KEY NOTES

- C1 - SW6091 - RELIABLE WHITE
- C2 - SW6086 - SAND DUNE
- C3 - SW6088 - NUTTHATCH
- M1 - ENVIRONMENTAL STONE - THIN STONE  
AUTUMN CUT STONE

## 3 COLOR & MATERIALS

REVISIONS				CT	06351	COLOR EXTERIOR ELEVATIONS & NOTES
REV	DATE	BY	DESCRIPTION			
1	REV1					
2	REV2					
3	REV3					
4	REV4					
5	REV5					
6	REV6					

AutoZone Store No. 3661  
98 RIVER ROAD

Architect: Lew Ellis  
123 South Front Street  
Memphis, Tennessee 38103  
TEL: 901-495-8600 FAX: (901) 495-8969  
For Bidding & Contractor Information Contact:  
McGraw - Hill Construction Tel. 615-884-1017  
www.construction.com

RECEIVED


SEP 07 2021  
TOWN CLERKS OFFICE  
TOWN OF LISBON  
3 per.

08-13-21


7N2-L

CE1

48.46 sq. ft.  
37.7 sq.ft.

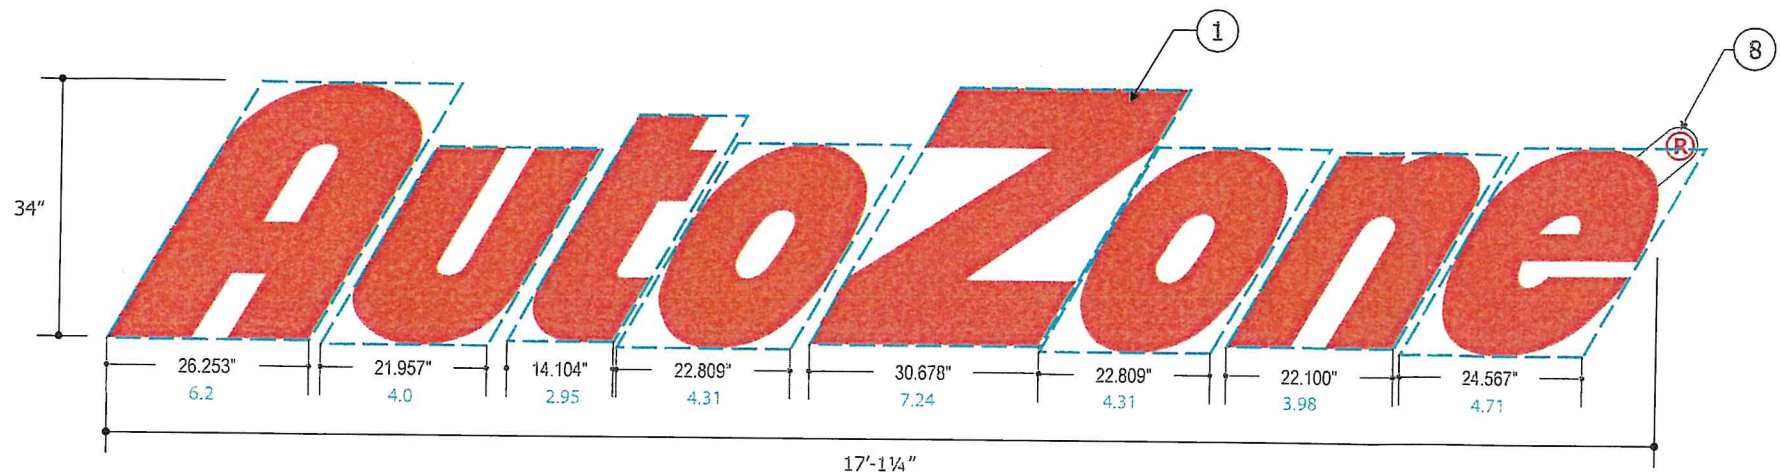


FRONT VIEW  
SCALE: 1/2" = 1'-0"

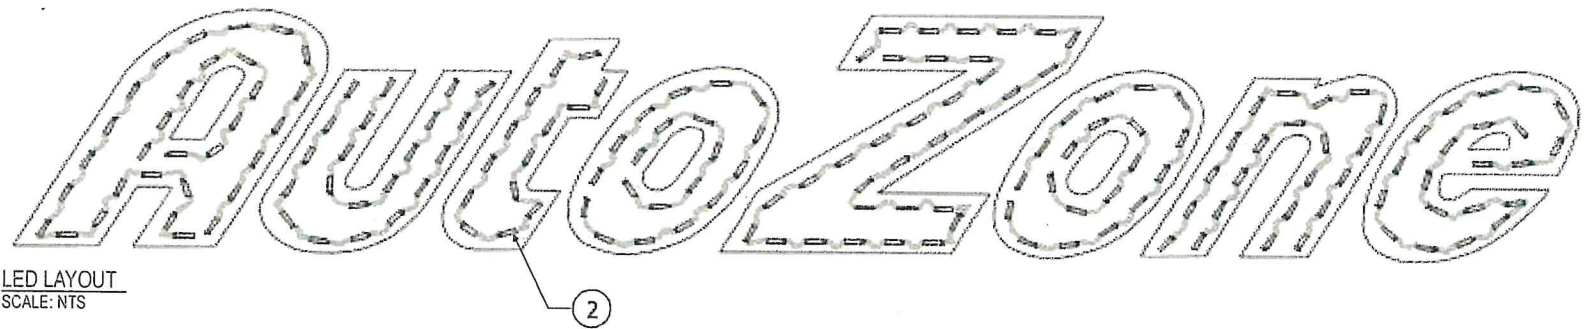

LED LAYOUT  
SCALE: NTS

MATERIAL BREAKDOWN			MATERIAL LIST			
GEMXRD-1	Modules	P/S	LED Module			
A	31.0	1		GEMXRD-1	182 Mod	91 Ft
U	21.0					
T	14.0		GEPS12-60U-NA	4 Ea		
O	20.0		GEPS12-20	0 Ea		
Z	33.0	1	Supply Wire	9409	165 Ft	
O	20.0		Choose one wire connector	192160005	50 Ea	
N	22.0			191600041	50 Ea	
E	21.0		End Caps	191600041	34 Ea	

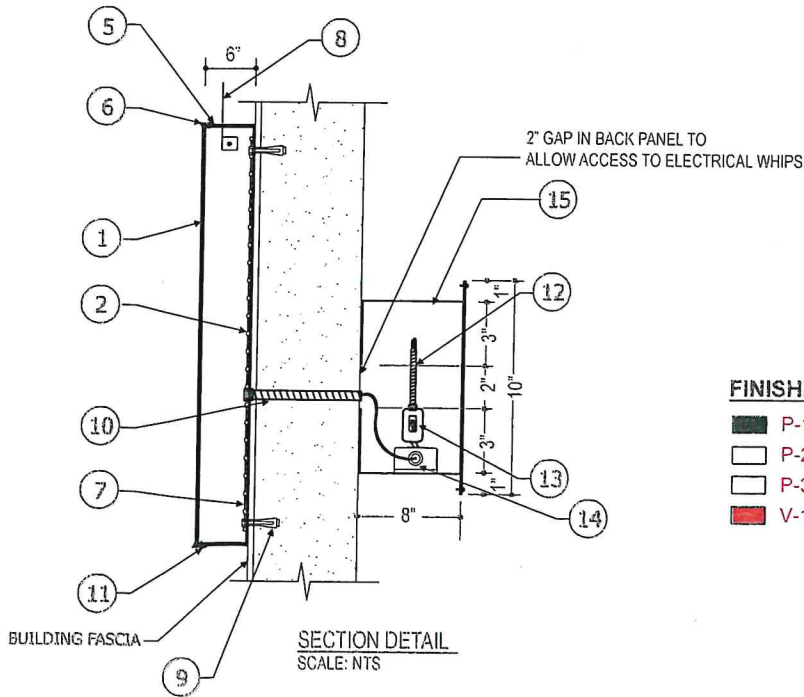

**FINISHES:**

- P-1 GLOSS BLACK
- P-2 RUSTOLEUM 20-9109 WHITE PRIMER
- P-3 SHERWIN WILLIAMS RELIABLE WHITE
- V-1 SIGN TECH (ARLON) 2500-2662 RED CAST FLEX VINYL

**REVISIONS**

 
REV.	DATE	BY	DESCRIPTION
1			
2			
3			
4			
5			

**CALL OUTS:**

- 3/16" THK PIGMENTED PLEXIGLAS RED 2662 AUTOZONE LETTERS.
- AUTOZONE LETTERS INTERNALLY ILLUMINATED w/ GE TETRA MAX RED LED.
- 6" PRE-FINISHED .040 BLACK/WHITE ALUMINUM RETURNS LETTER LOCKED/STAPLED TO BACK AND CAULKED. (INSIDE OF LETTERS/STRIPES TO BE WHITE)
- 1" GLOSS BLACK JEWELITE TRIM FASTENED TO LETTERS/STRIPES w/ MINIMUM #8 SHEET METAL SCREWS PAINTED GLOSS BLACK P-1. SPACING SHALL NOT EXCEED 18". NO FEWER THEN FOUR (4) SCREWS PER FACE.
- PRE-FINISHED .063 BLACK/WHITE ALUMINUM BACK LETTER LOCKED/STAPLED TO RETURN AND CAULKED. (INSIDE OF LETTERS/STRIPES TO BE WHITE)
- WHITE ALUMINUM TAB w/ RED @ VINYL APPLIED FIRST SURFACE V-1.
- REFER TO ENGINEERING FOR MOUNTING REQUIREMENTS.
- 3/8" FLEXIBLE CONDUIT (GREEN FIELD).
- 1/4" WEEP HOLES.
- 120V - 20 AMP PRIMARY ELECTRICAL CONNECTIONS, TO BE MADE BY LICENSED ELECTRICAL CONTRACTORS.
- UL APPROVED ELECTRICAL SHUT OFF SWITCH.
- TETRA POWER SUPPLY MOUNTED TO BOTTOM OF RACEWAY COVER.
- 8" x 10"H x .063 ALUMINUM FOUR SIDED INTERIOR RACEWAY w/ REMOVABLE FACE. P-2, P-3 (REQUIRED FOR ALL SIGNS).

**NOTES:**

- ALL VISIBLE SCREW HEADS & POP RIVETS PAINTED GLOSS BLACK.
- RACEWAY SHIPPED IN (5) PIECES (2-BACKS, 1-FRONT, 2-ENDS) & ASSEMBLED IN FIELD.



THIS SIGN IS INTENDED TO BE INSTALLED IN ACCORDANCE WITH THE REQUIREMENTS OF ARTICLE 600 OF THE NATIONAL ELECTRIC CODE AND/OR OTHER APPLICABLE LOCAL CODES. THIS INCLUDES PROPER GROUNDING AND BONDING OF THE SIGN.

Job Number  
**XXXX**

QTY: (1)

JOB NAME: CITY, STATE  
**AUTO ZONE - STORE #**  
**34" AZ CHANNEL LETTERS - NS**

**JONES SIGN**  
Your Vision. Accomplished.  
1711 SCHEURING ROAD  
DE PERE, WI 54115  
TOLL FREE: 800-536-7446  
TEL: 920-983-6700  
FAX: 920-983-9145  
www.jonesign.com

Quality Grade:  
2

# of Circuits Req'd:  
1-20 AMP CIRCUIT

Amp Draw:  
2.6A

Voltage:  
120V

Project Manager:  
Mickey Wiskow

Salesman:  
Mike Bjorklund

Revision Date:  
(SEE REVISION TABLE)


Date:  
06.05.14

Drawn By:  
JS



Sheet No. :  
**1**

58 D/F INTERNALLY ILLUMINATED PYLON (Qty 1) - AZ2FS60-96-24LBX

SQUARE FOOTAGE: 40

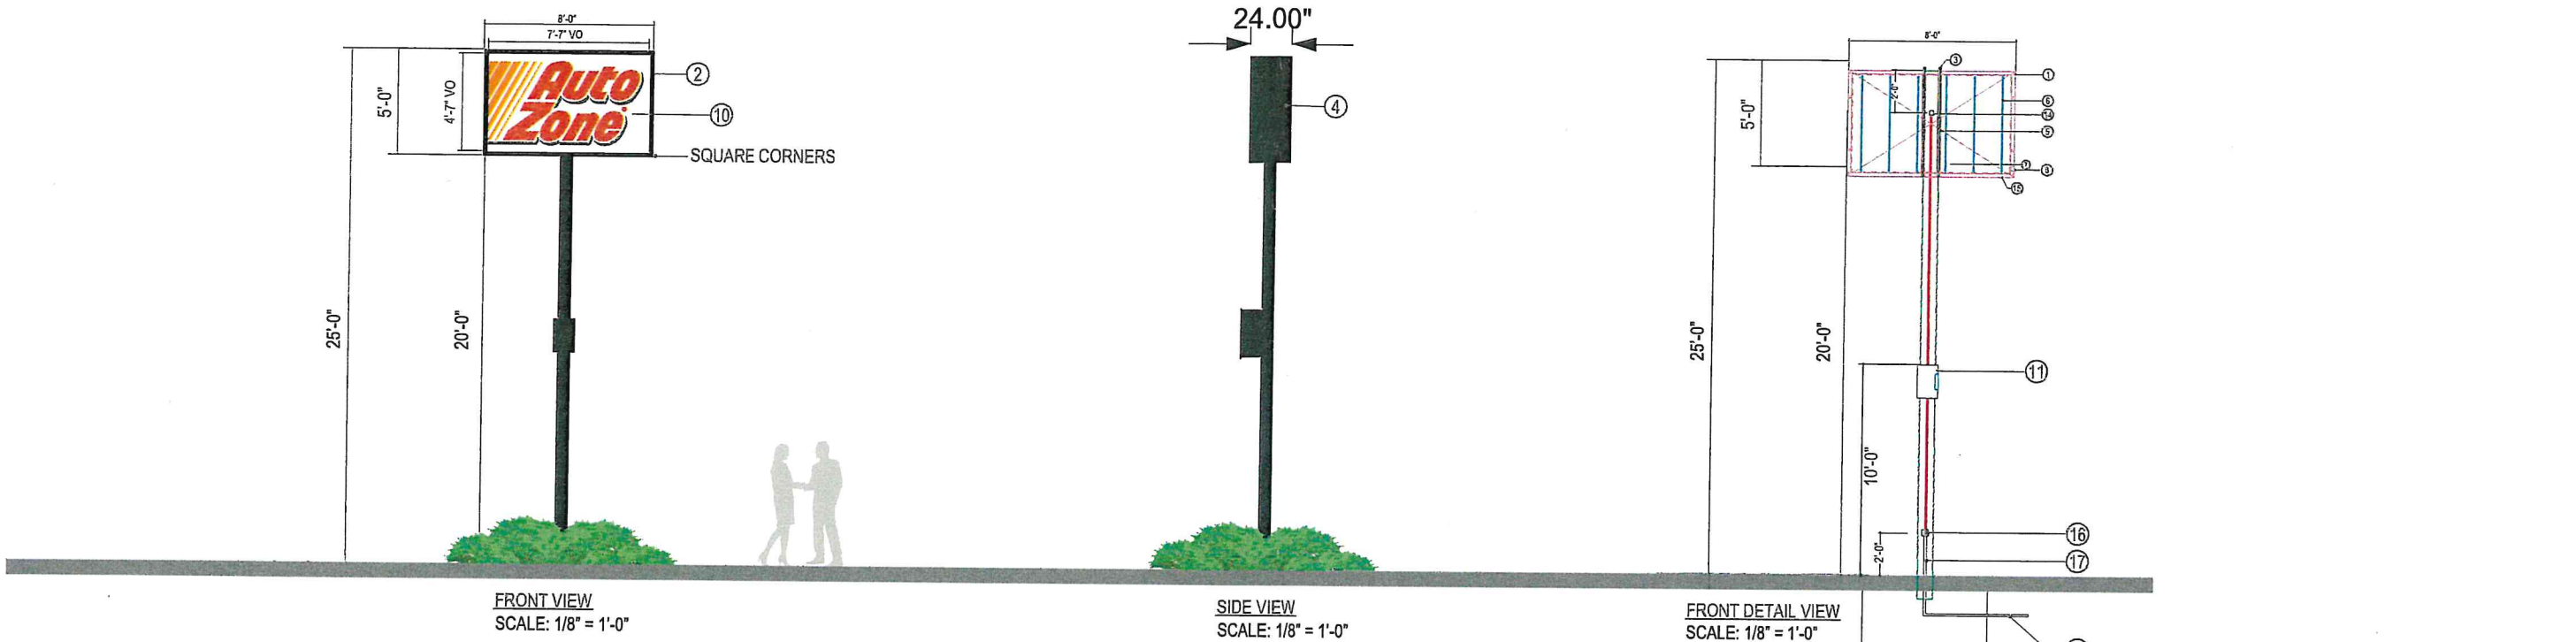


- SPECIFICATIONS**
- 1. 1" x 2" x .125" ALUMINUM TUBE FRAME / WELDED CONSTRUCTION
  - 2. 2 1/2" FORMED .063" PRE-FINISHED BLACK/WHITE ALUMINUM RETAINER FASTENED TO CABINET w/ #8 x 1/2" LG HEX WASHER HEAD TEK SCREWS
  - 3. (2) 1/2" LIFTING EYES
  - 4. .063" PRE-FINISHED BLACK/WHITE ALUMINUM RETURNS FASTENED TO CABINET w/ 1/8" POP RIVETS
  - 5. 1 3/4" x 1 3/4" x 1/8" STEEL ANGLE ADJUSTABLE SADDLE MOUNT SYSTEM
  - 6. INTERNALLY ILLUMINATED w/ GE LED STICKS
  - 7. POWER SUPPLY LOCATED INSIDE .063" PRE-FINISHED BLACK/WHITE ALUMINUM WATERPROOF ENCLOSURE
  - 8. ETL APPROVED DISCONNECT SWITCH ON CABINET / 20AMP/120VOLT
  - 9. 4" ROUND ALUMINUM VENT / BOTH ENDS OF CABINET
  - 10. .150" WHITE LEXAN FACES w/ HANG BARS / FIRST SURFACE APPLIED ARLON TRANSLUCENT VINYL GRAPHICS V-1, V-2, V-3
  - 11. REFER TO ENGINEERING FOR STEEL SUPPORT REQUIREMENTS / PORTION OF POLE INSIDE CABINET TO BE PAINTED P-1 / PORTION OF POLE OUTSIDE CABINET TO BE PAINTED P-8
  - 12. 3/4" PVC CONDUIT w/ PRIMARY ELECTRICAL WIRING BELOW GRADE PER LOCAL CODE / N.I.C. BY OTHERS
  - 13. CONCRETE FOOTING / REFER TO ENGINEERING FOR POLE EMBEDMENT SPECIFICATION AND FOOTING REQUIREMENTS
  - 14. ELECTRICAL HAND HOLE
  - 15. DRAIN HOLES / MINIMUM 4 REQUIRED
  - 16. MULTI-TAP FIXTURES TO ACCOMMODATE ELECTRICAL EXISTING ON SITE
  - 17. CONDUIT EXPOSED / NO HOLE REQUIRED BELOW GRADE

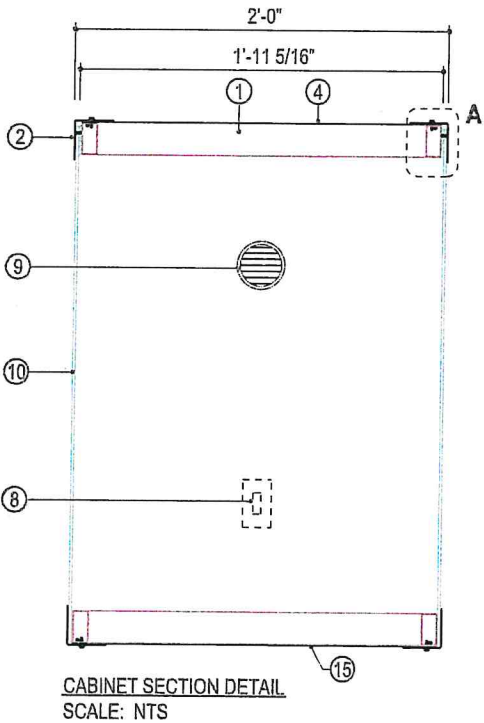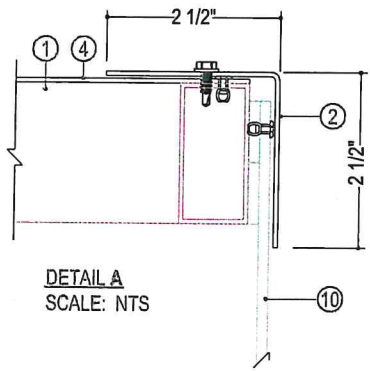

- COLORS/FINISHES**
- P-1 RUSTOLEUM 20-9109 WHITE PRIMER
  - P-8 GLOSS BLACK
  - V-1 ARLON 44 ORANGE HI PERF. TRANSLUCENT VINYL
  - V-2 ARLON 22 BLACK HI PERF. TRANSLUCENT VINYL
  - V-3 ARLON 143 POPPY RED HI PERF. TRANSLUCENT VINYL

VARIABLES		SIZE	FINISHED SIZE	V.O.	CORNERS	AMPS	CIRCUITS	ILLUMINATION	POWER SUPPLIES
58		40 SQ FT	5'-0" x 8'-0"	4'-7" x 7'-7"	SQUARE	1.10	120V (1) 20 AMP CIRCUIT	(6) GE LED TETRA STICKS	(1) GE 24V-100W POWER SUPPLY

NOTES  
- STANDARD CABINET DEPTH IS 24" / TO BE ADJUSTED AS NEEDED PER ENGINEERING

<div>JONES SIGN</div> <div>Your Vision. Accomplished.</div> <div>WWW.JONESSIGN.COM</div>	<div>JOB #: 257653-R0</div> <div>DATE: 08.30.21</div> <div>DESIGNER: M. Woodyard</div> <div>SALES REP: M. Bjorklund</div> <div>PROJ MGR: T. Christensen Awe</div>	REV.	DATE	BY	DESCRIPTION	CLIENT APPROVAL	DATE		AUTOZONE #3661	SHEET NUMBER	
		1	08.08.08	JX	JX001						
		2	08.08.08	JX	JX001						LISBON, CT 06351
		3	08.08.08	JX	JX001						
		4	08.08.08	JX	JX001	LANDLORD APPROVAL	DATE			1.0	
		5	08.08.08	JX	JX001						
		6	08.08.08	JX	JX001						
		7	08.08.08	JX	JX001						
		8	08.08.08	JX	JX001						
		9	08.08.08	JX	JX001	QC			DESIGN PHASE: CONCEPTUAL		
		10	08.08.08	JX	JX001						

This is an original, unpublished drawing by Jones Sign Co., Inc. It is for your personal use in conjunction with a project being planned for you by JONES SIGN. It is not to be shown to anyone outside of your organization, nor is it to be used, reproduced, copied or exhibited in any fashion. Use of this design or the salient elements of this design in any sign done by any other company, without the express written permission of JONES SIGN, is forbidden by law and carries a civil forfeiture of up to 25% of the purchase price of the sign. JONES SIGN will endeavor to closely match colors, including PMS, where specified. We cannot guarantee exact matches due to varying compatibility of surface materials and paints used. All sizes and dimensions are illustrated for client's conception of project and are not to be understood as being exact size or exact scale.